



2 Floor Plan
 Scale: 1/4" = 1'-0"

POLE BARN	John & Jill Romeo
2	21 Sebastian Court Hopewell Junction, NY 12533
	SCALE: AS NOTED
	Date: Nov. 21, 2005

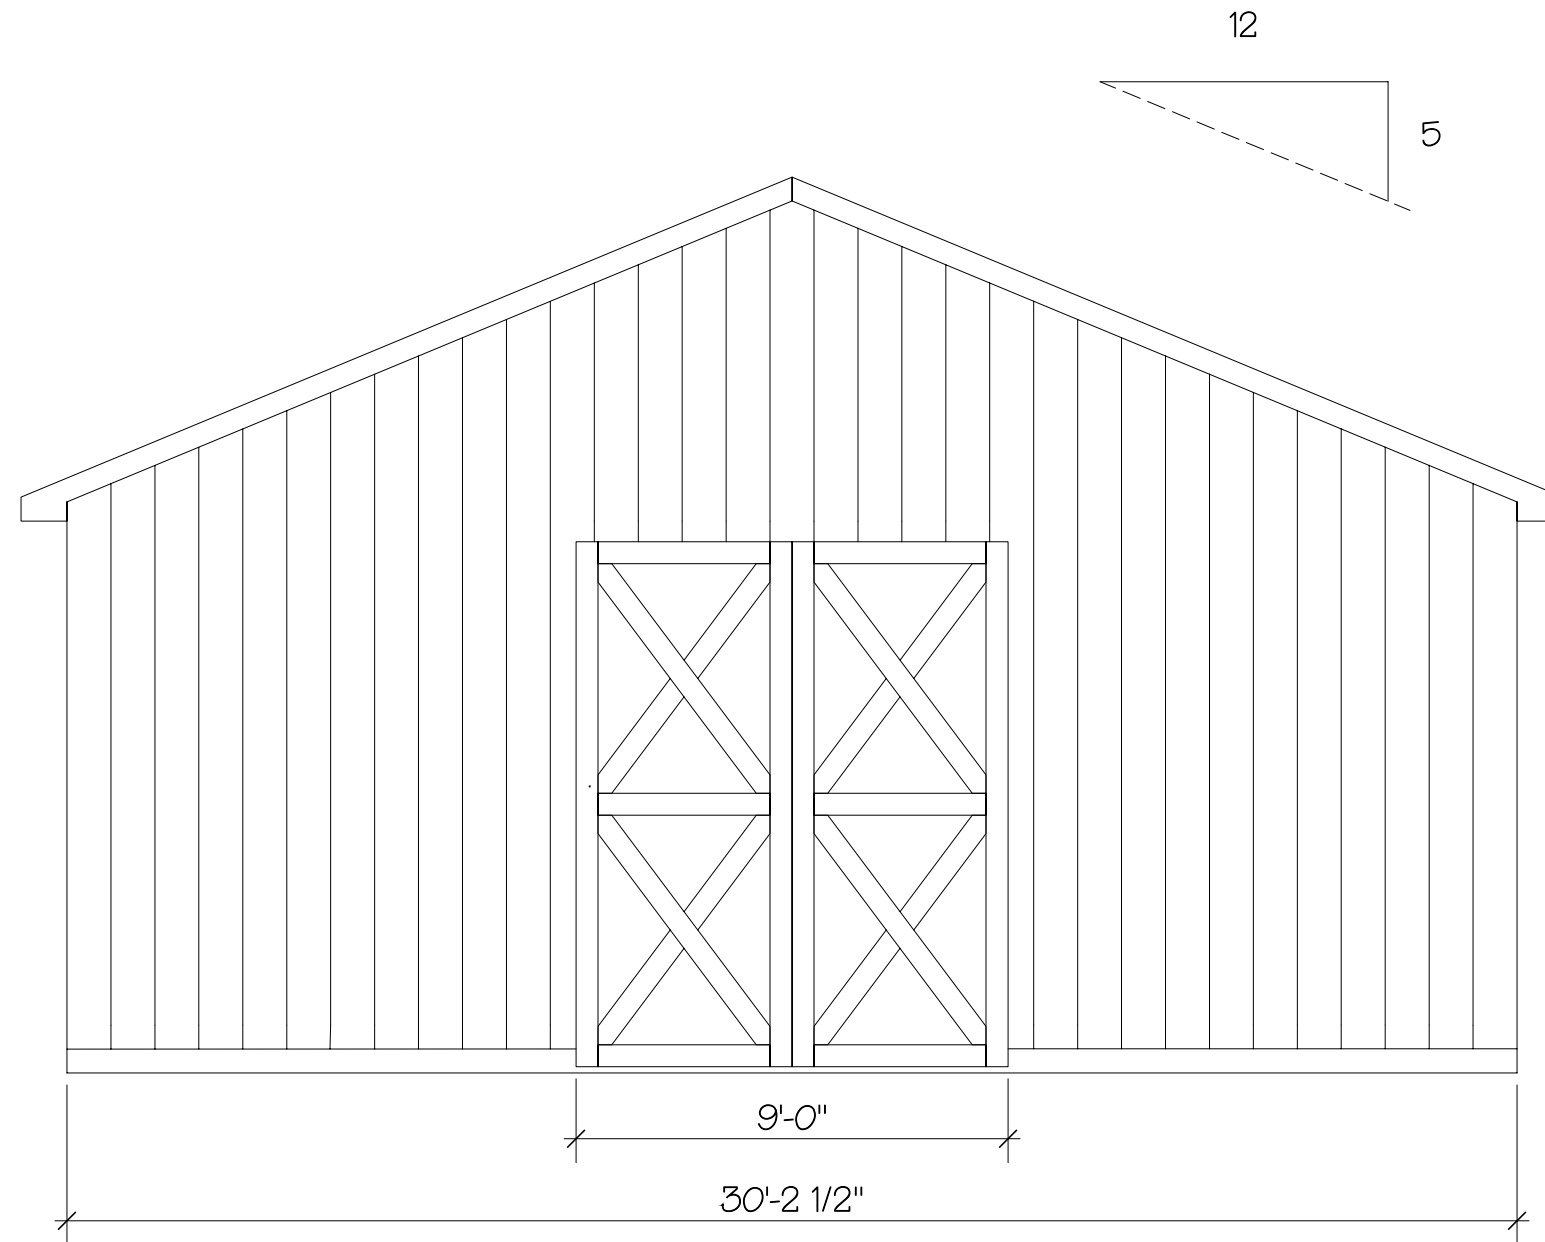


3 Front Elevation
 Scale: 1/4" = 1'-0"

POLE BARN	John & Jill Romeo
3	21 Sebastian Court Hopewell Junction, NY 12533
	SCALE: AS NOTED
	Date: Nov. 21, 2005

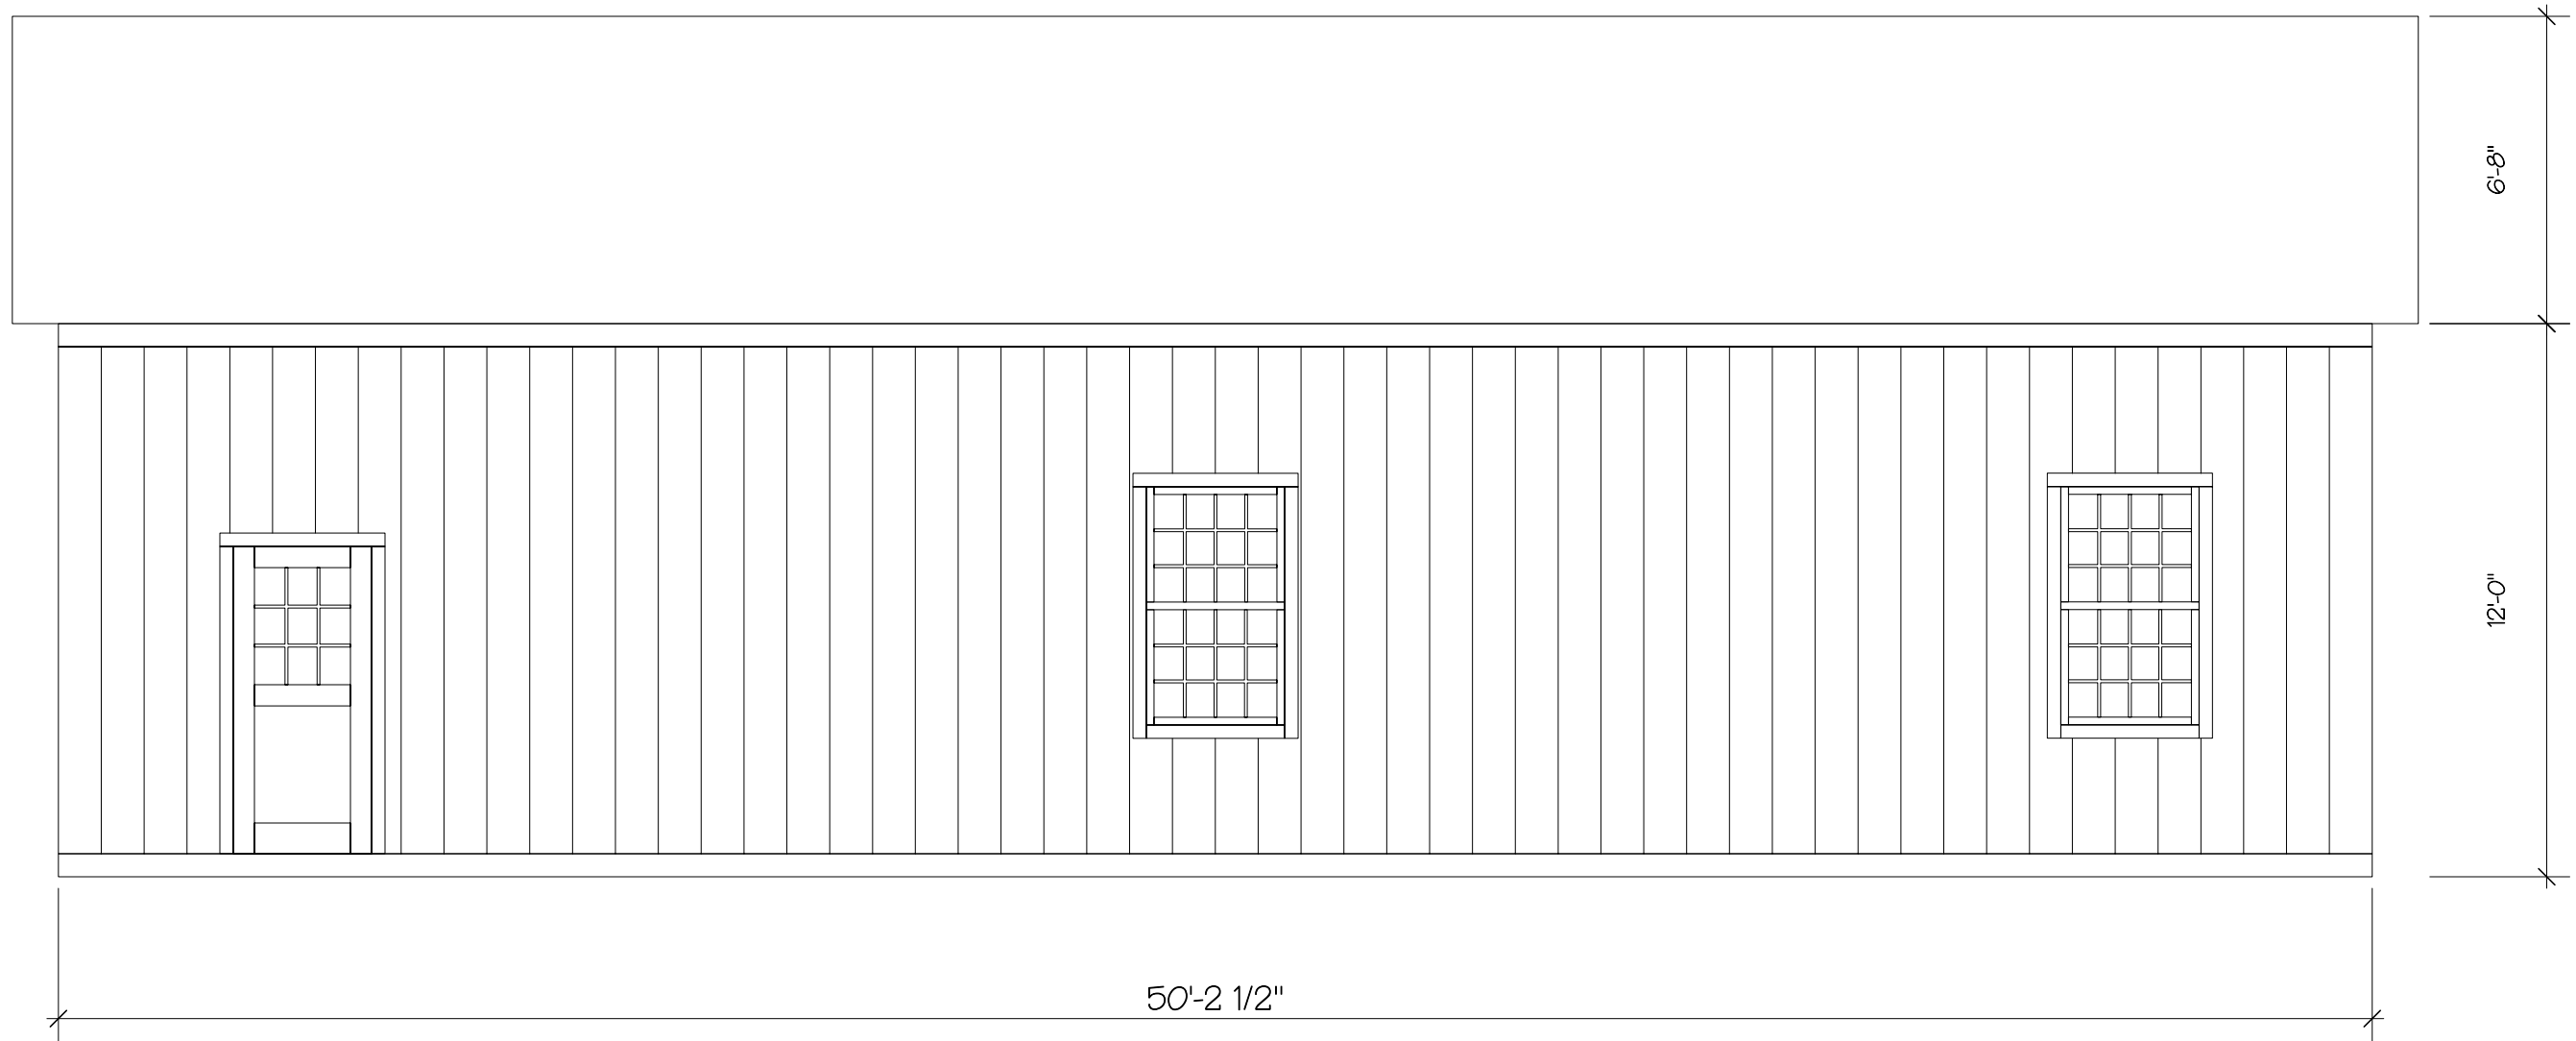


4 Side Elevation
 Scale: 1/4" = 1'-0"

POLE BARN	John & Jill Romeo
4	21 Sebastian Court Hopewell Junction, NY 12533
	SCALE: AS NOTED
	Date: Nov. 21, 2005

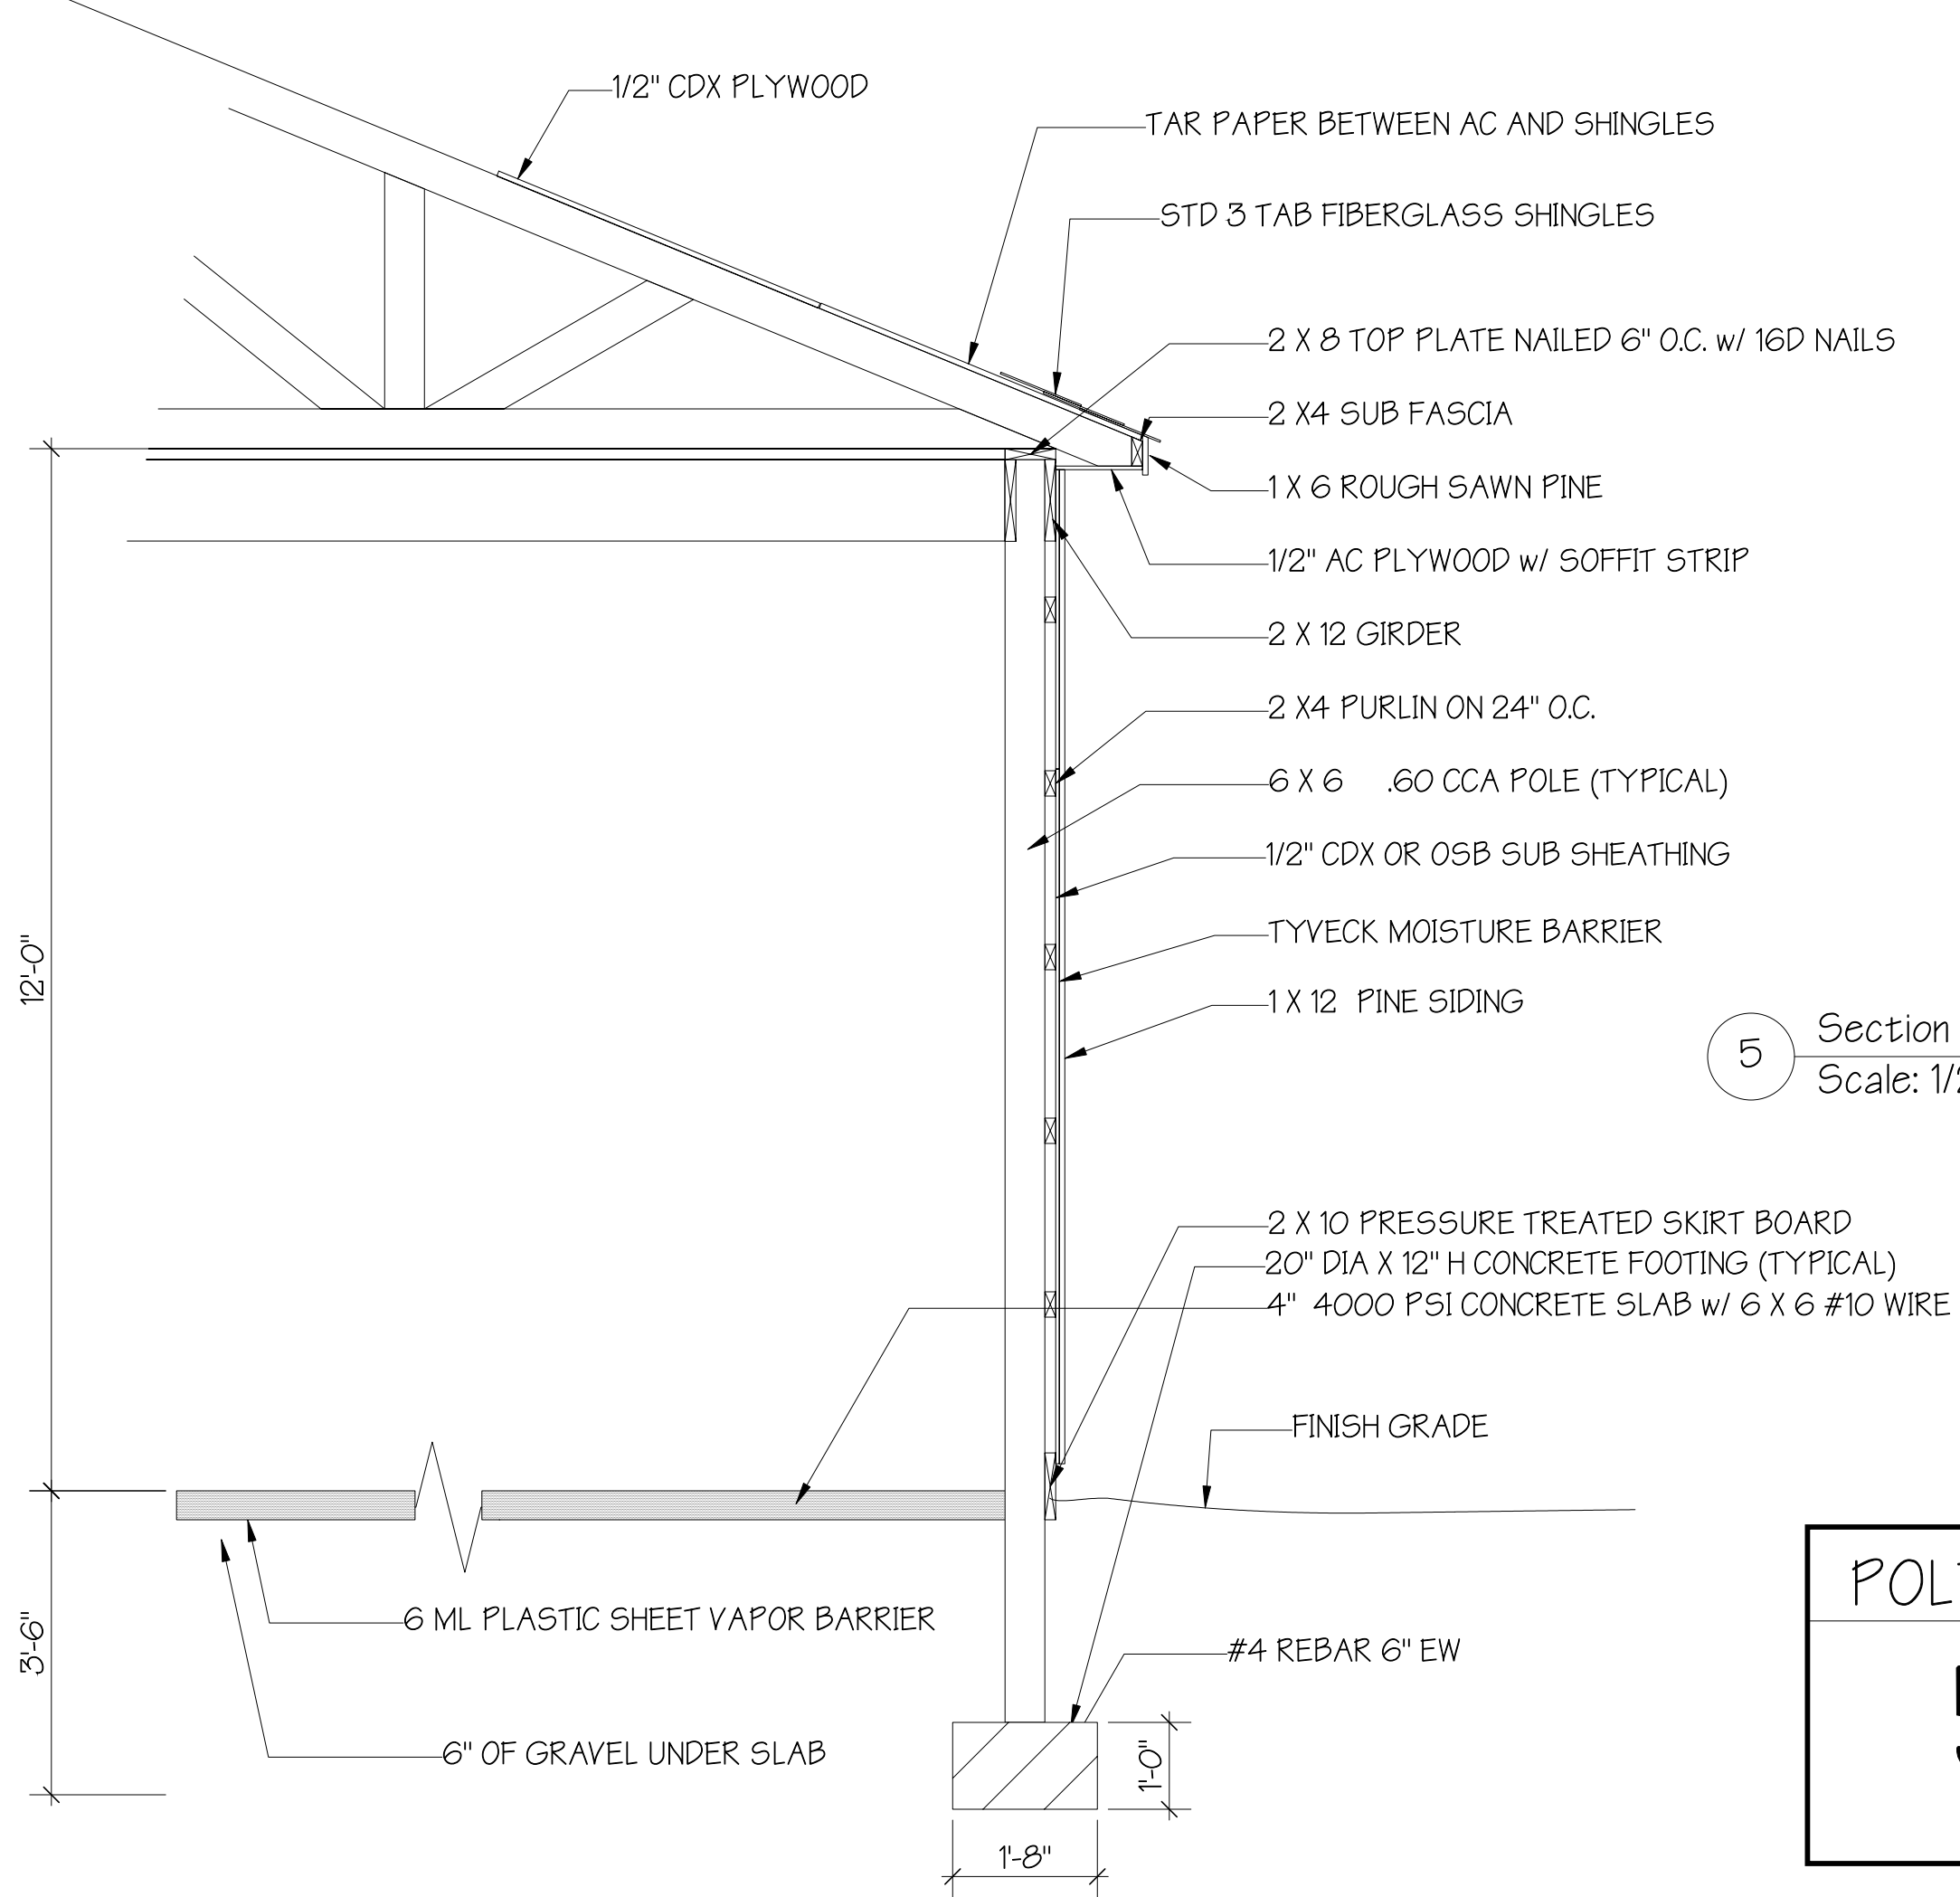

5 Section
 Scale: 1/2" = 1'-0"

POLE BARN	John & Jill Romeo
5	21 Sebastian Court Hopewell Junction, NY 12533
	SCALE: AS NOTED
	Date: Nov. 21, 2005

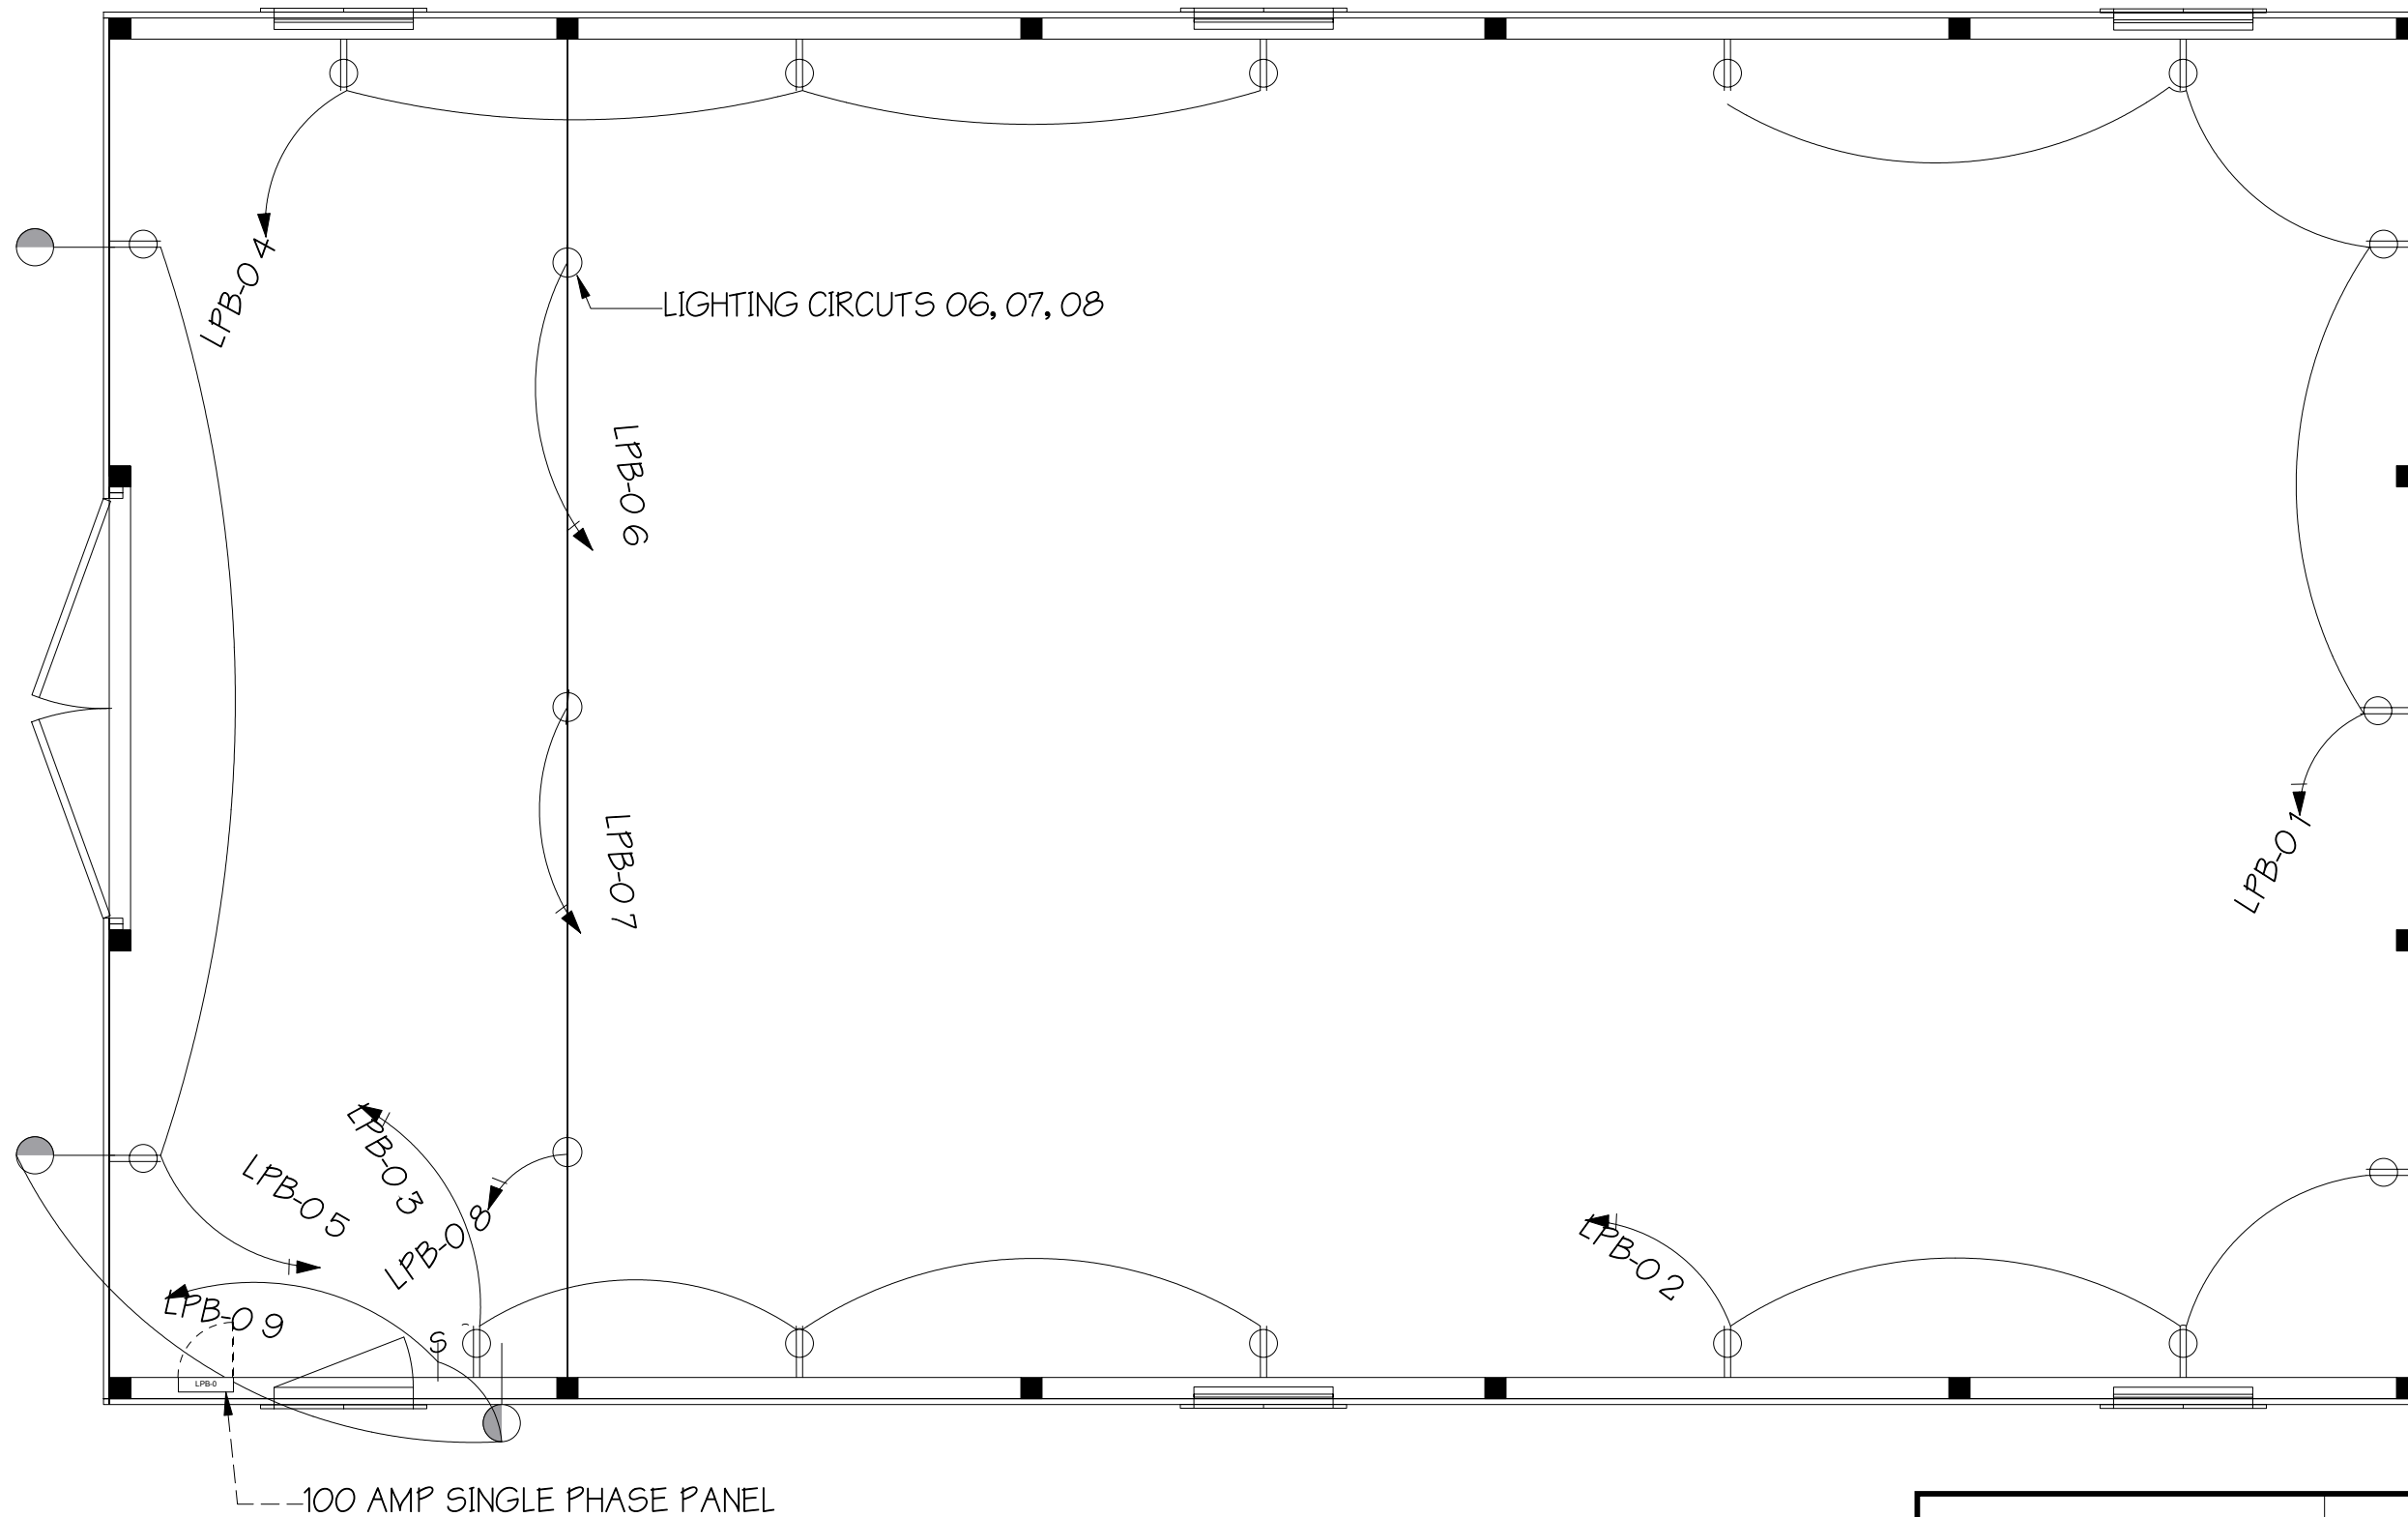

6 Electrical Plan
 Scale: 1/4" = 1'-0"

POLE BARN	John & Jill Romeo
6	21 Sebastian Court Hopewell Junction, NY 12533
	SCALE: AS NOTED
	Date: Nov. 21, 2005